


# PLUMBING FIXTURE SCHEDULE

TAG	MANUFACTURER	MODEL	FIGURE COLOR	FITTINGS	REMARKS
WC-1	AMERICAN STANDARD	CADET AQUA-LITE 2168-100	WHITE	SUPPLY WITH STOPS FLUSH VALVE: DELTA 47T316	PRESSURE ASSISTED FLUSH TANK, HANDICAPPED WATER CLOSET, VITREOUS CHINA, ELONGATED BOWL, OLSONITE 10CC SEAT (WHITE).
L-1	AMERICAN STANDARD	ROXALYN 0195-073	WHITE	FAUCET: DELTA 21T423 TRAP: DELTA 33T295 SUPPLIES: DELTA 47T512	VITREOUS CHINA LAVATORY BOWL, SELF RIMMING WALL MTD. SUPPLY FITTINGS WITH STOPS, LESS POP-UP, OPEN GRID STRAINER, OFFSET HANDICAPPED P-TRAP EXPOSED PIPING TO BE INSULATED BELOW LAV.
HWH-1	RHEEM	EGSP-20	-	-	PROVIDE WITH 1500W, 120V ELEMENT & POWER CORD. PROVIDE WITH DRAIN PAN. 20 GAL CAPACITY. PIPE DRAIN PAN (1 1/2"Ø) TO NEAREST DRAIN.

## FIXTURE CONNECTION SCHEDULE

FIXTURE	WATER	SANITARY	VENT
W.C.	15 MM	100 MM	50 MM
URINAL	20 MM	50 MM	30 MM
LAVATORY	15 MM	30 MM	30 MM
SINK	15 MM	50 MM	30 MM
F.D.	-	100 MM	50 MM

PLUMBING NOTES: 1. PROVIDE TRAP PRIMERS ON ALL FLOOR DRAINS  
2. VENT ALL FIXTURES TO CODE.

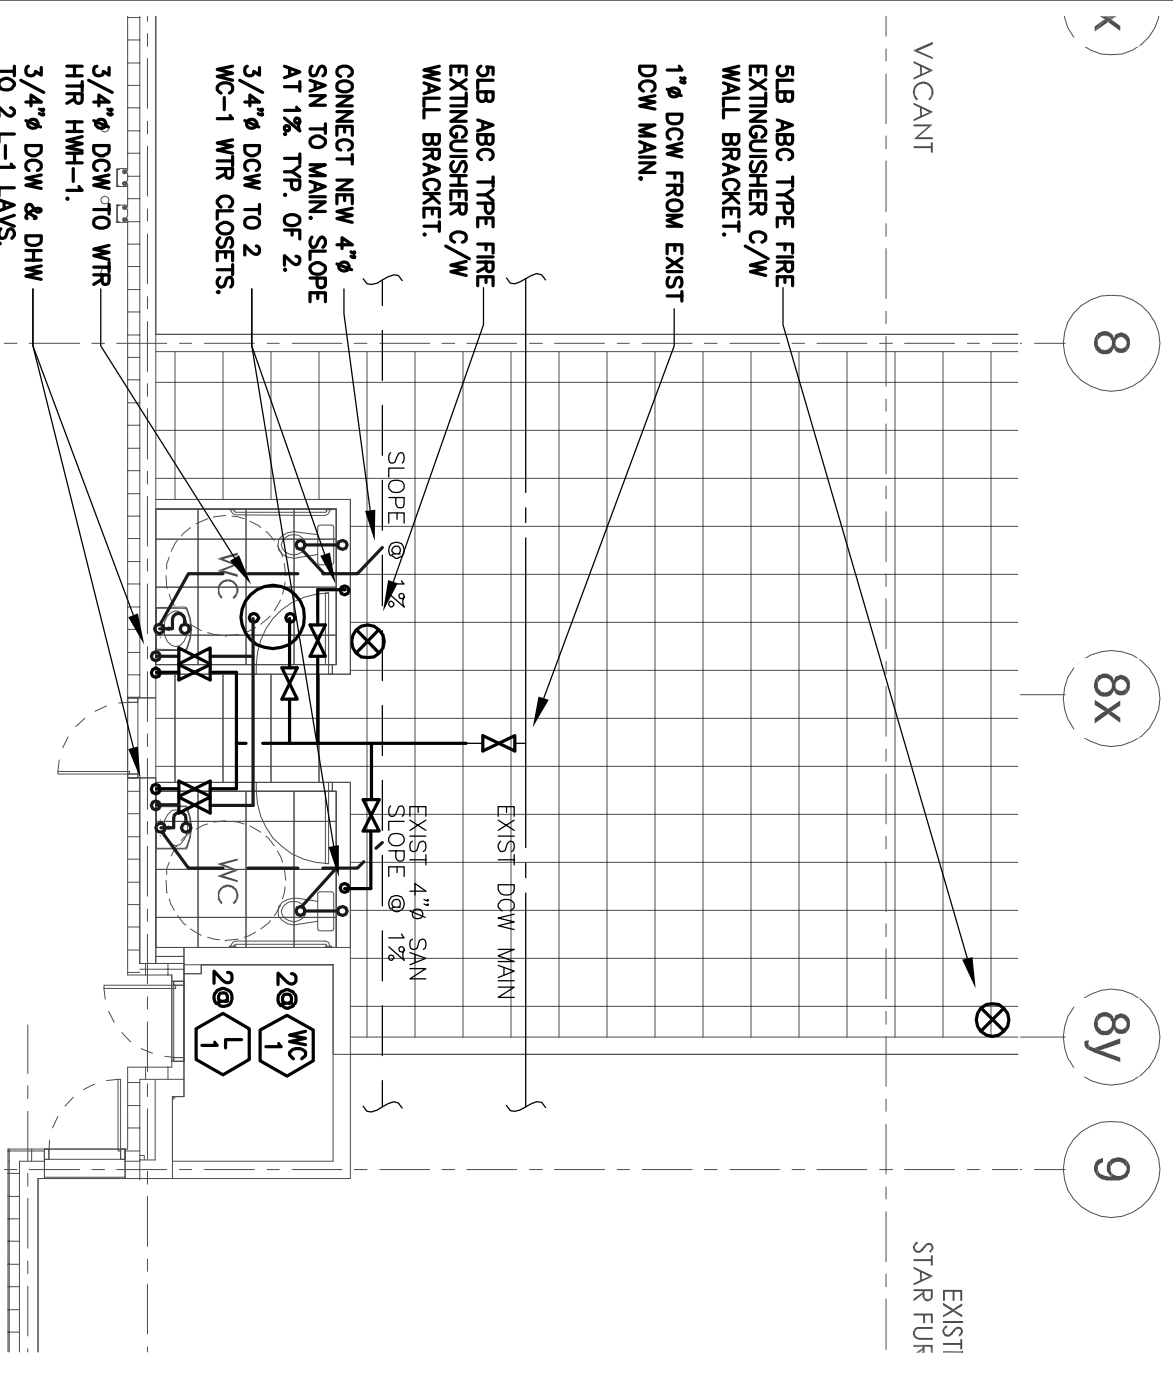

PLBG NOTES:  
1. VENT ALL PLBG  
FIXTURES TO CODE.

## 1 MAIN FLOOR PLBG & DRAINAGE PLAN

SCALE: 1/8"=1'-0"

M-2

**DMH Designs Ltd.**  
117 Royal Oak Green NW  
Calgary, Alberta T3G 6A7  
Tel: (403) 620-3170  
Fax: (403) 208-4185

PROJECT	Date	Scale
WEIGHT WATCHERS Unit C104, 20670 Langley Bypass Langley, BC.	03/04/12	1/8"=1'-0"
DRAWING TITLE MECHANICAL PLBG & DRAINAGE FLOOR PLANS		Dwg. No. M-2